


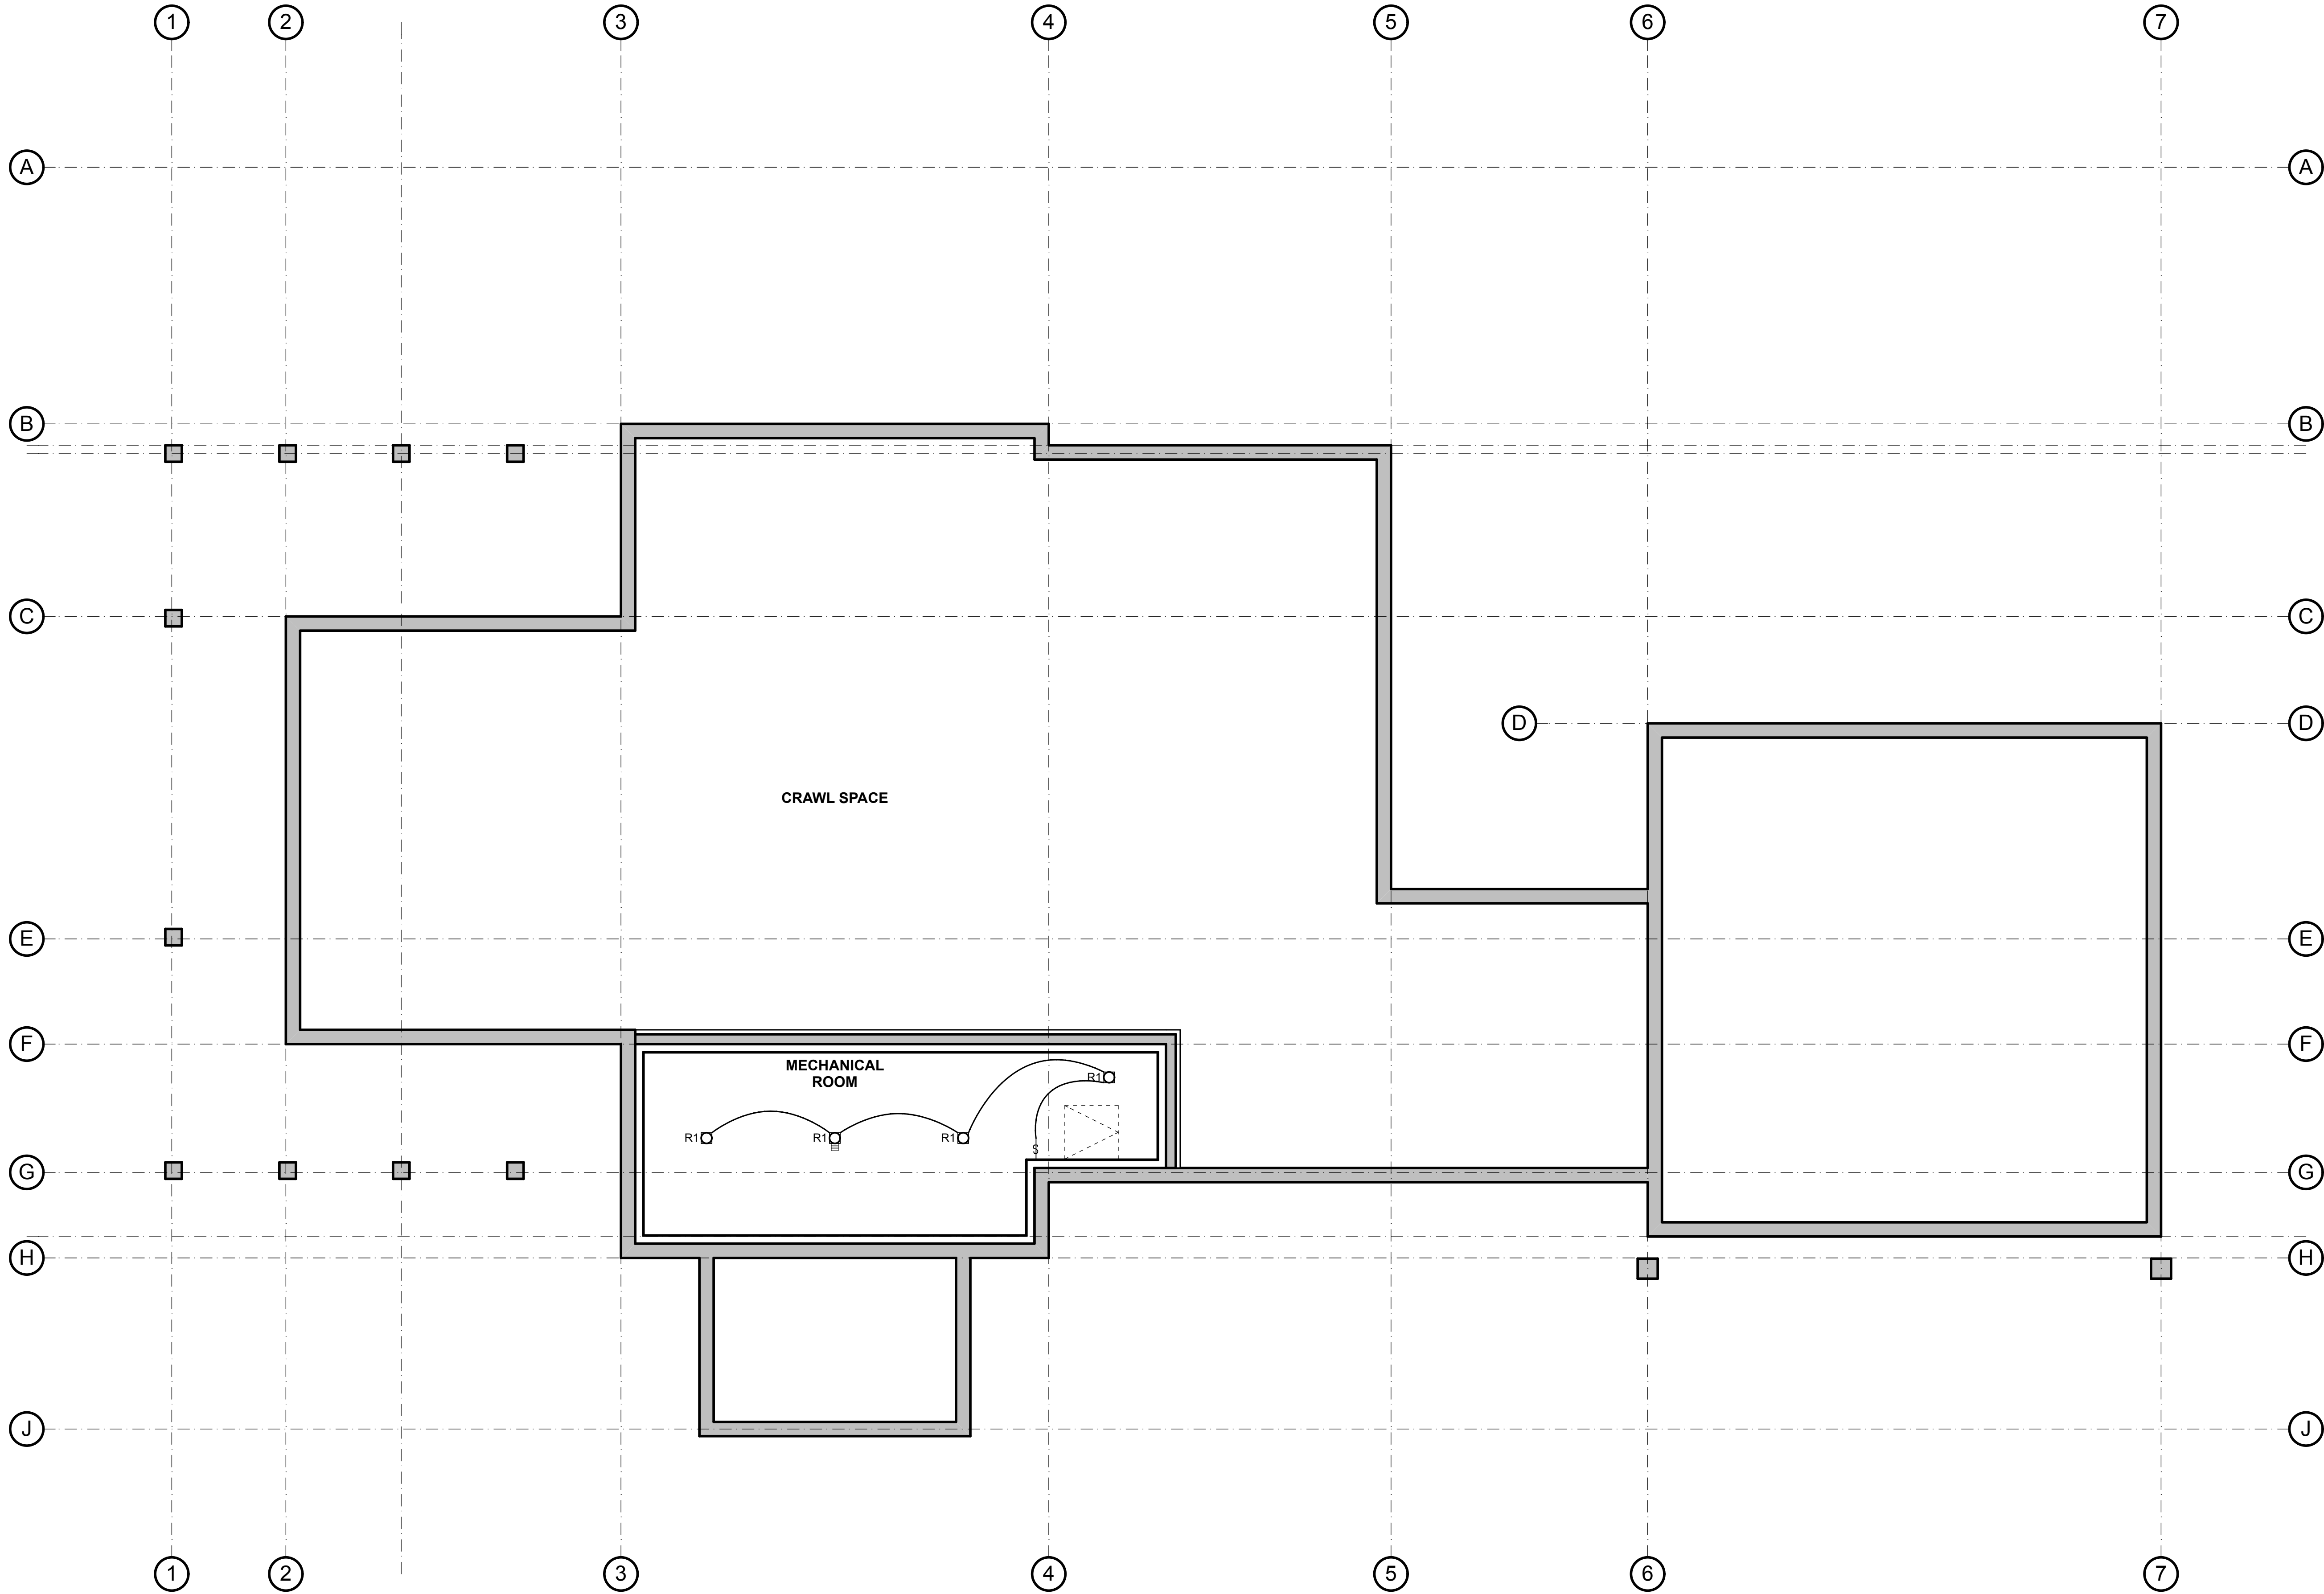

1 Lower Level Lighting and Electrical Plan
Scale: 1/4" = 1'-0"

Richardson Residence
5370 West Woodchuck Road
Lot 10, Unit 1, River Meadows Subdivision
Teton County, Wyoming

Ankeny
Architecture
and Design
P.O. Box 11062
Jackson, WY
83002
307.413.0904

Date/Revision:
12.18.18 SD Pricing Set
03.15.19 Revised Pricing
05.01.19 Interiors
05.10.19 Permit
06.28.19 Construction
01.22.20 Rev. 1 Set

Sheet:

LE2.1

Lighting Plan
1405.00 Richardson